



Z:\Weather Fleming\Veritas\5 Greentree Rd Marlton NJ\1st Floor\5 Greentree 01_EC_2021-0102_20220331.dwg

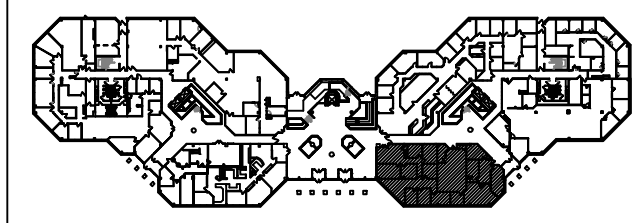

KEY PLAN - FIRST FLOOR
SCALE: NOT TO SCALE

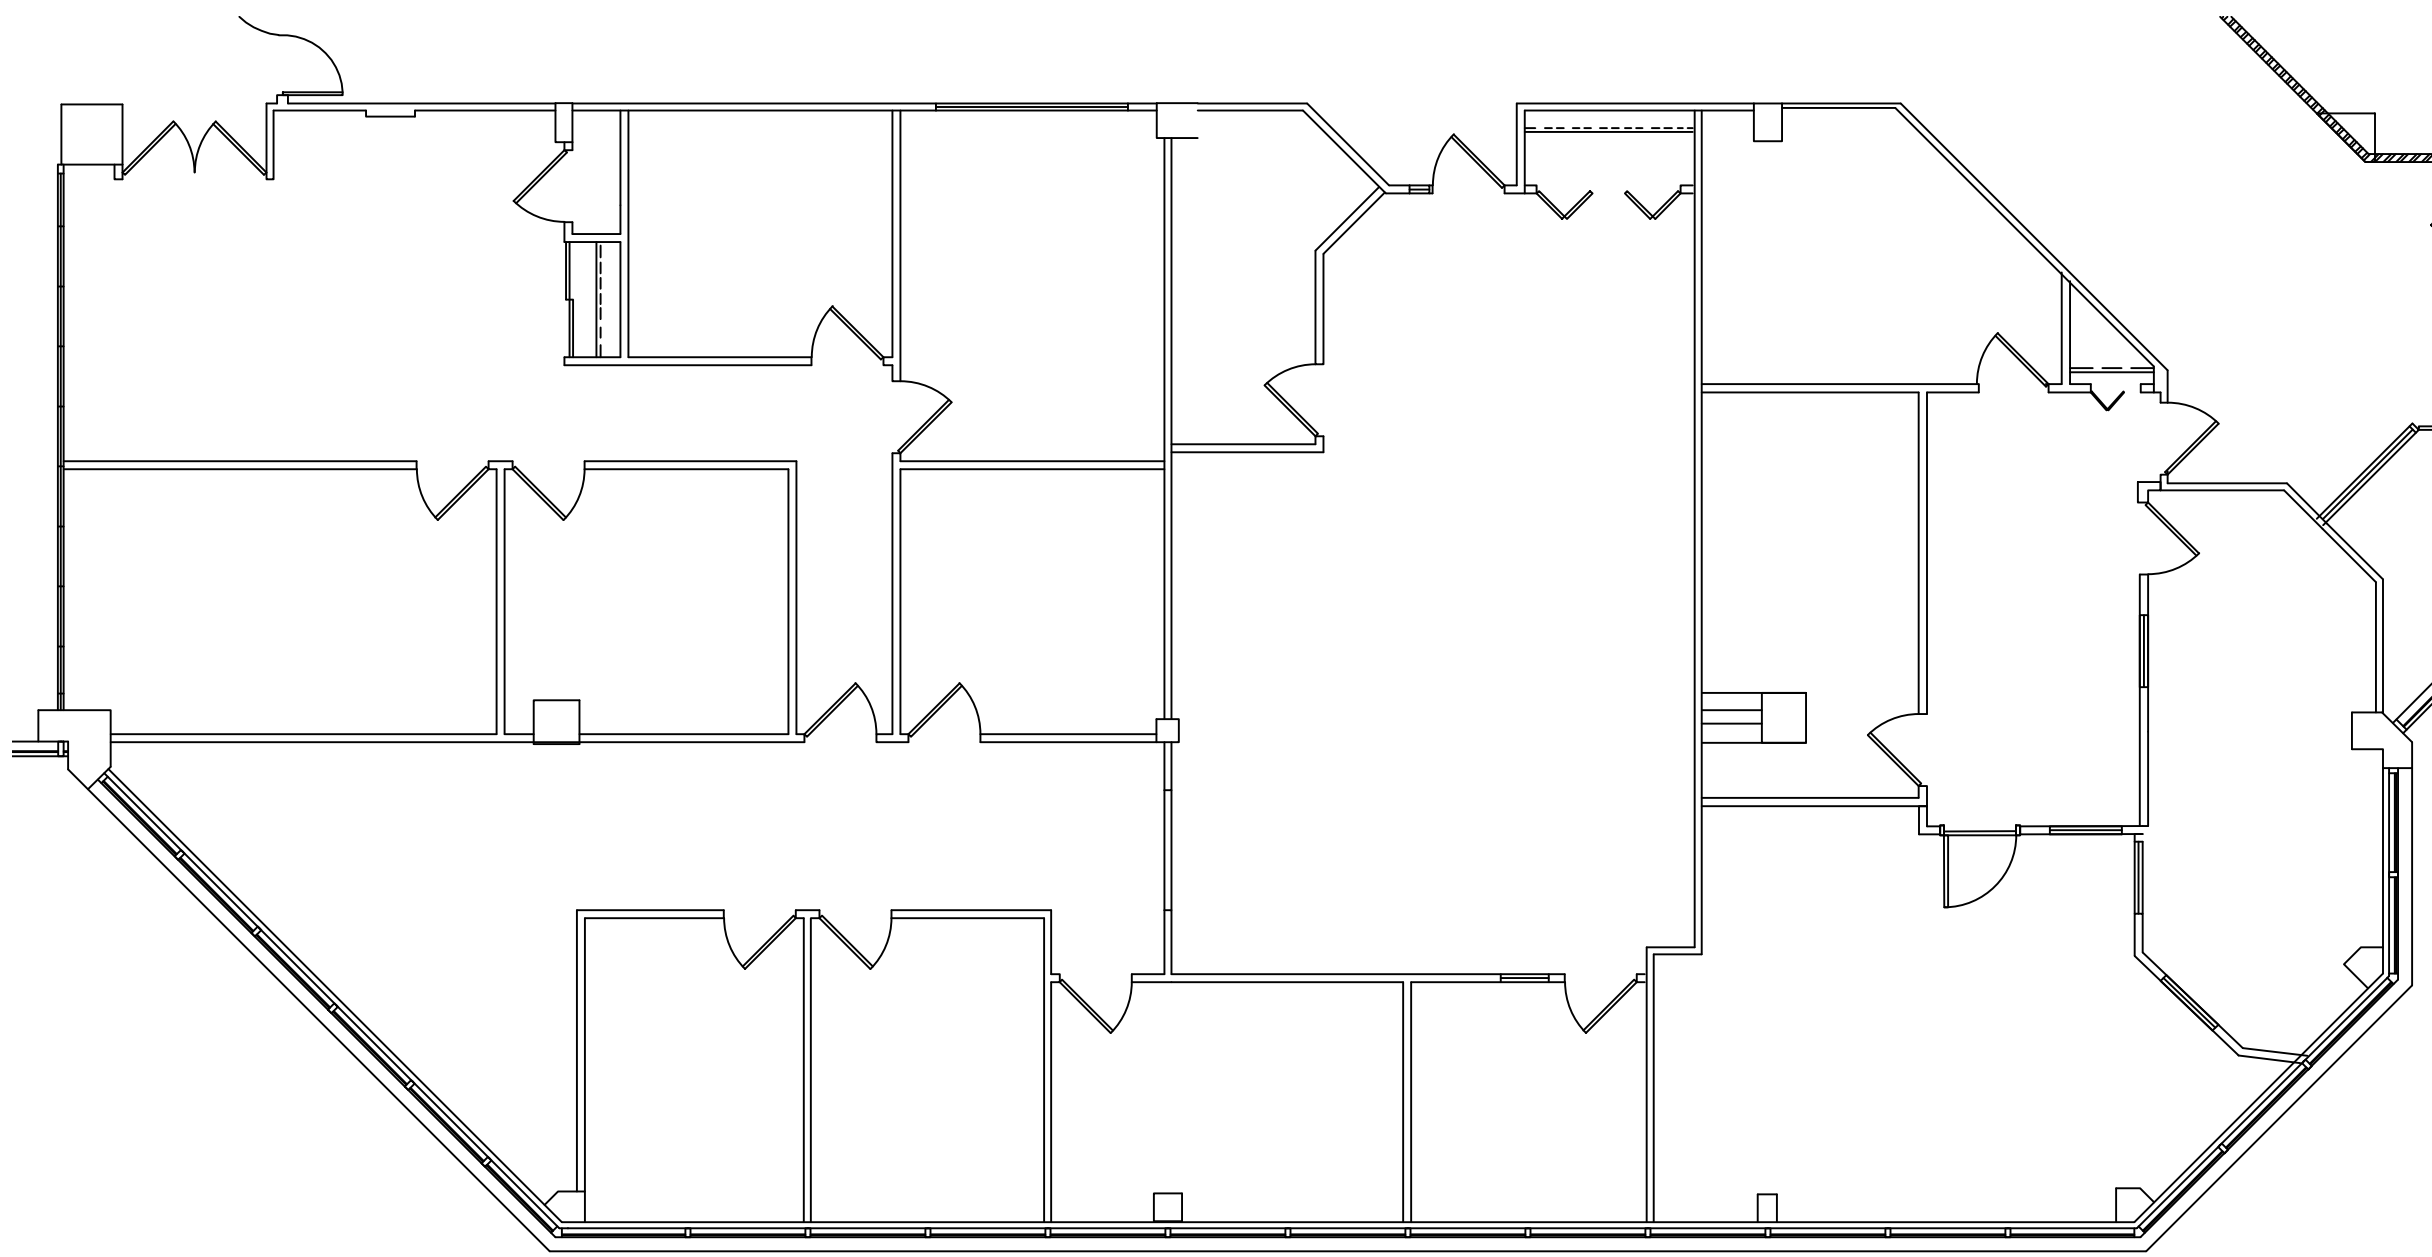

FLOOR PLAN
SCALE: 1/8" = 1'-0"



EXISTING CONDITIONS FOR:
SUITE 100
5 GREENTREE CENTER
MARLTON, NJ 08053

RHJ ASSOCIATES, PC
ARCHITECTS · PLANNERS · DESIGNERS

KING OF PRUSSIA, PA 610.337.4555 MOUNT LAUREL, NJ 856.252.0040 PHILADELPHIA, PA 215.279.5845 WILMINGTON, DE 302.482.2269
www.rhjassoc.com

DATE 12.29.2022
PROJECT NO. 2021-0102